




SOUTH ELEVATION
SCALE: $\frac{1}{8}'' = 1'-0''$

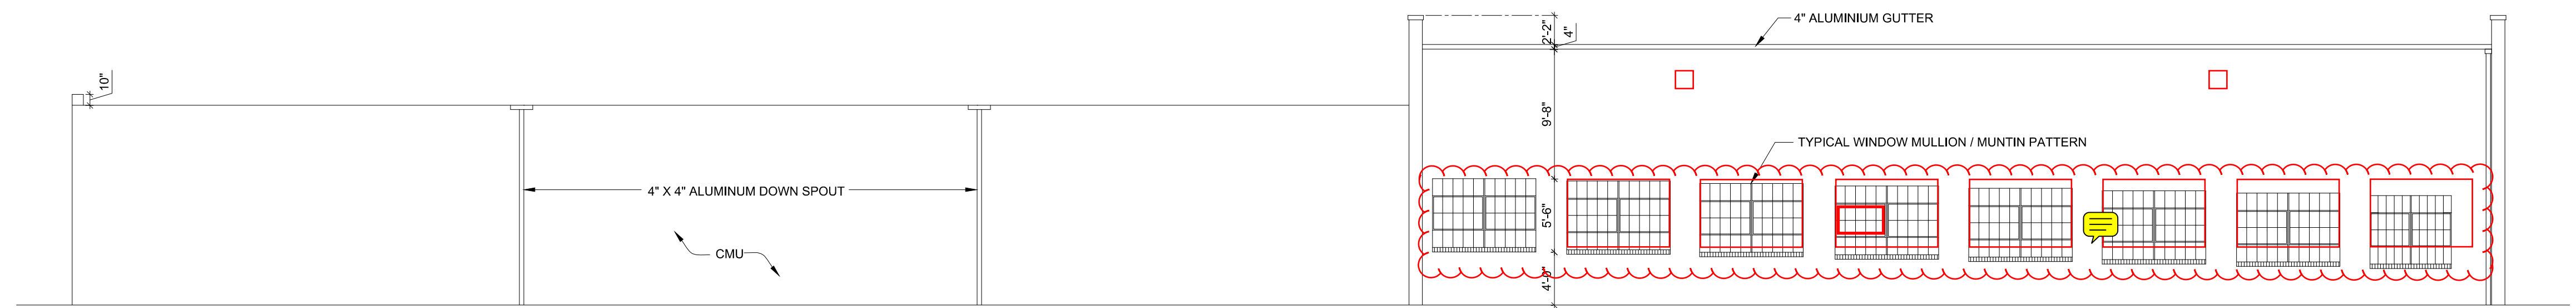


NORTH ELEVATION
SCALE: $\frac{1}{8}'' = 1'-0''$

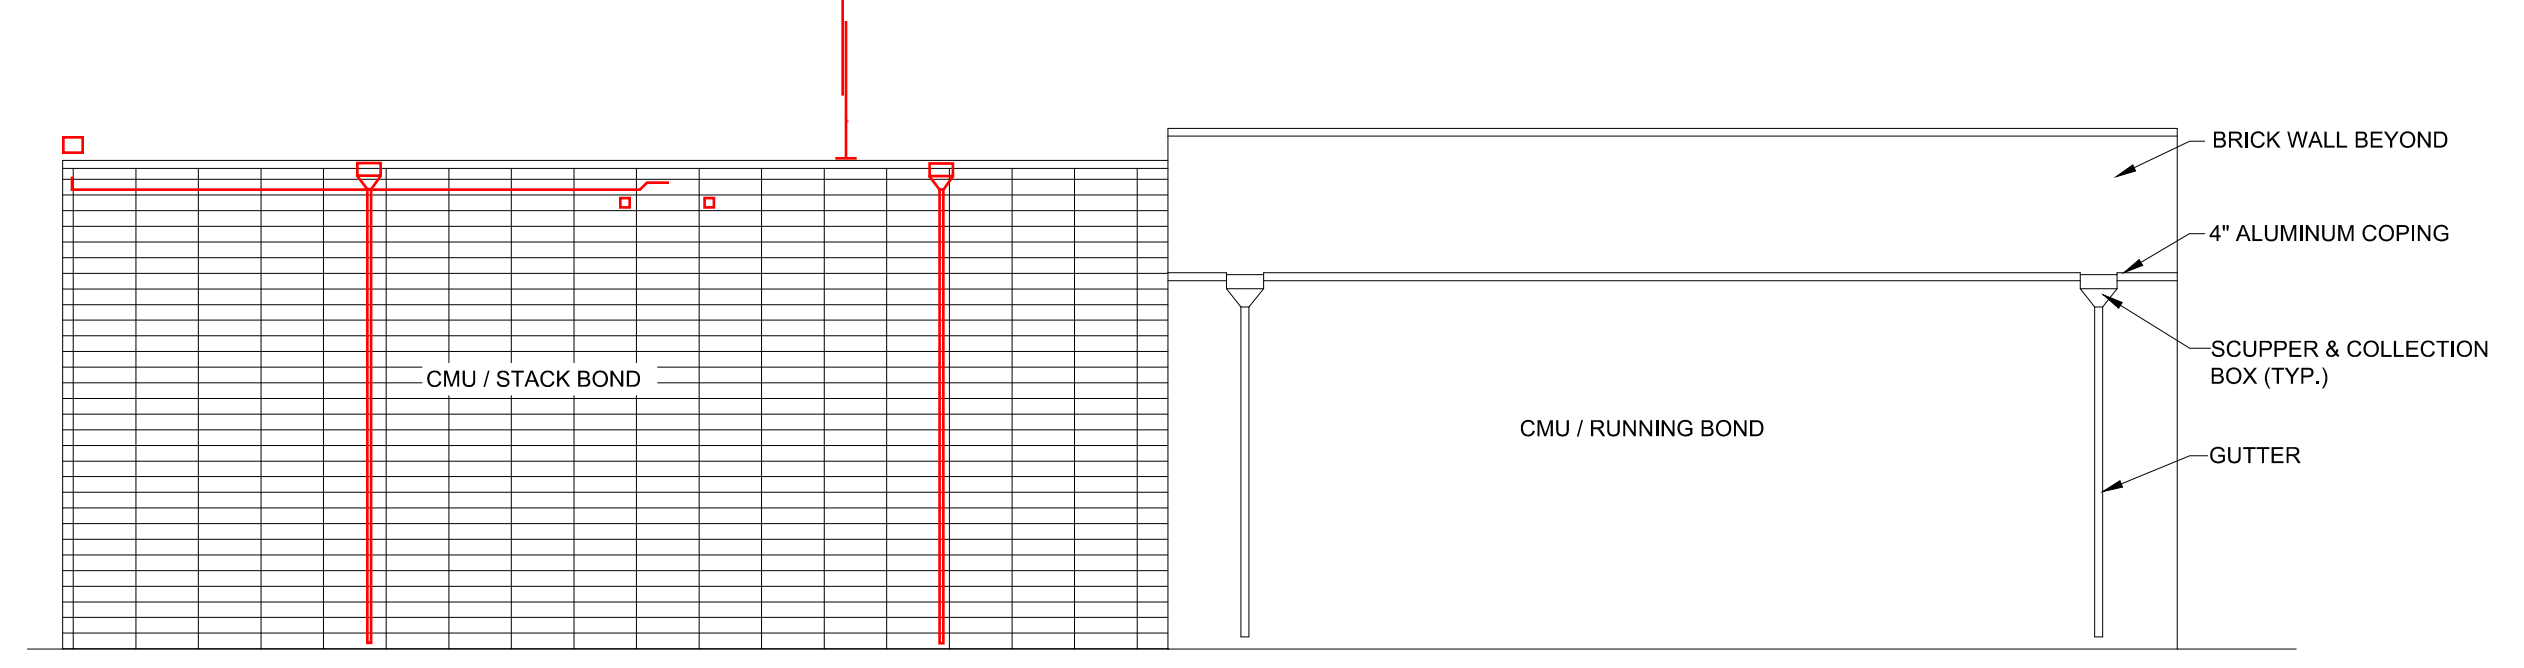

EAST ELEVATION
SCALE: $\frac{1}{8}'' = 1'-0''$

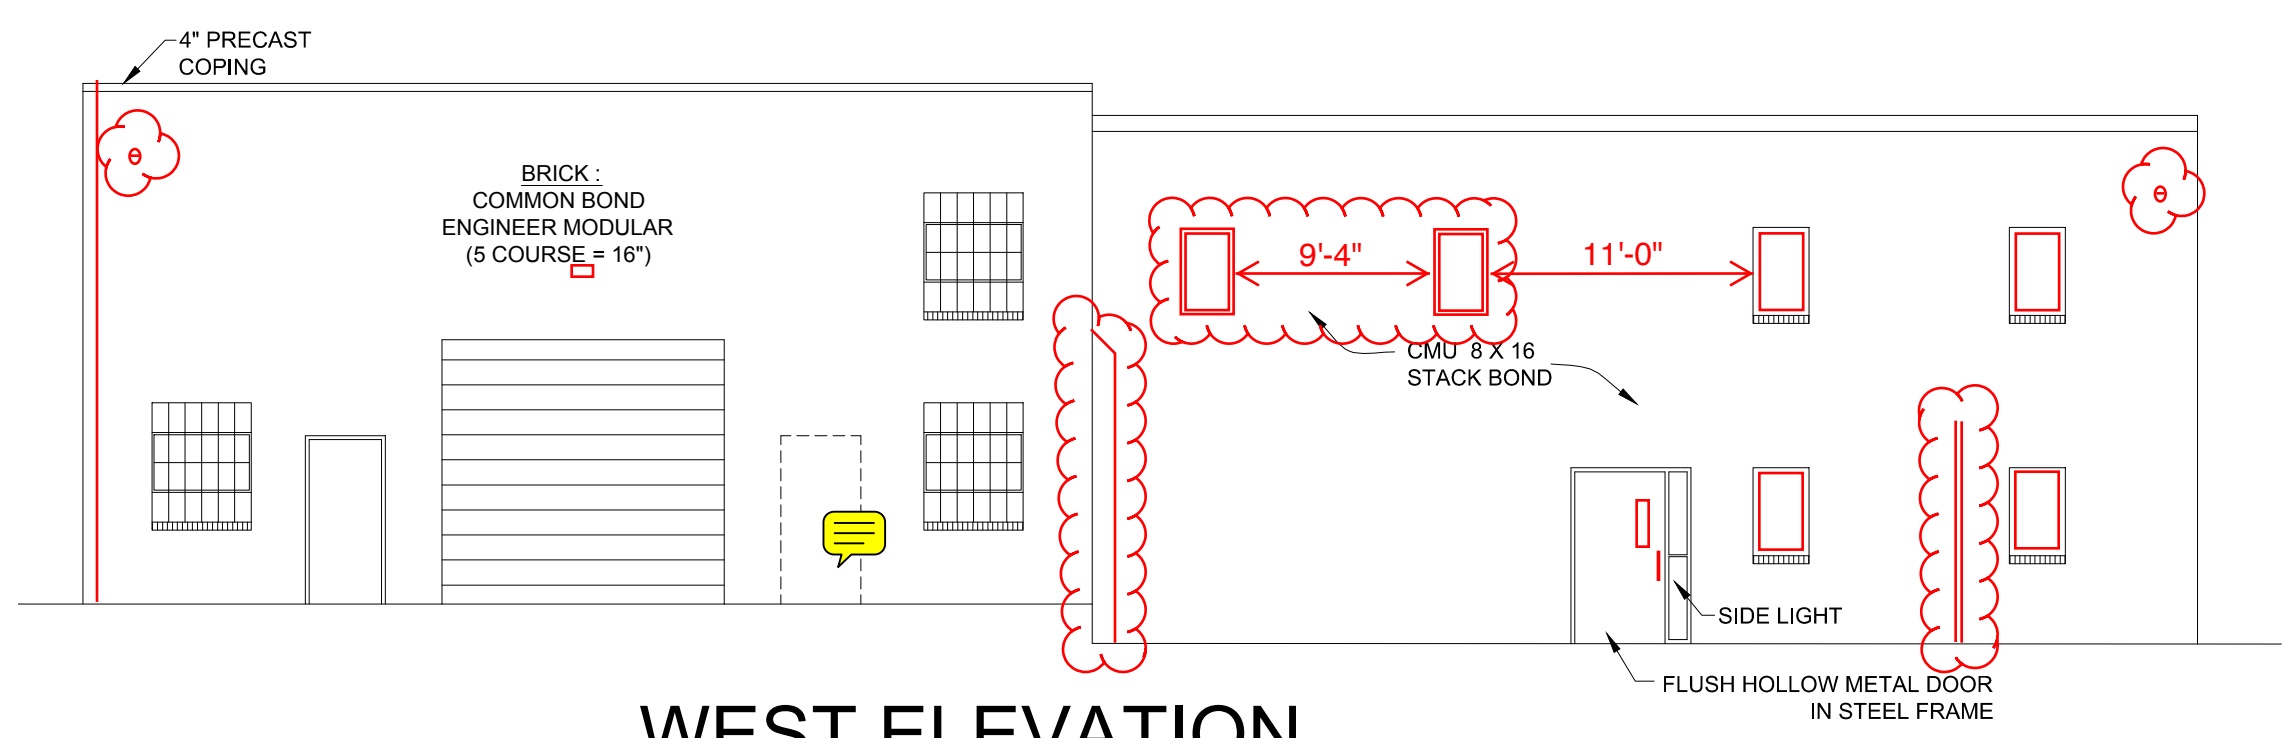


WEST ELEVATION
SCALE: $\frac{1}{8}'' = 1'-0''$

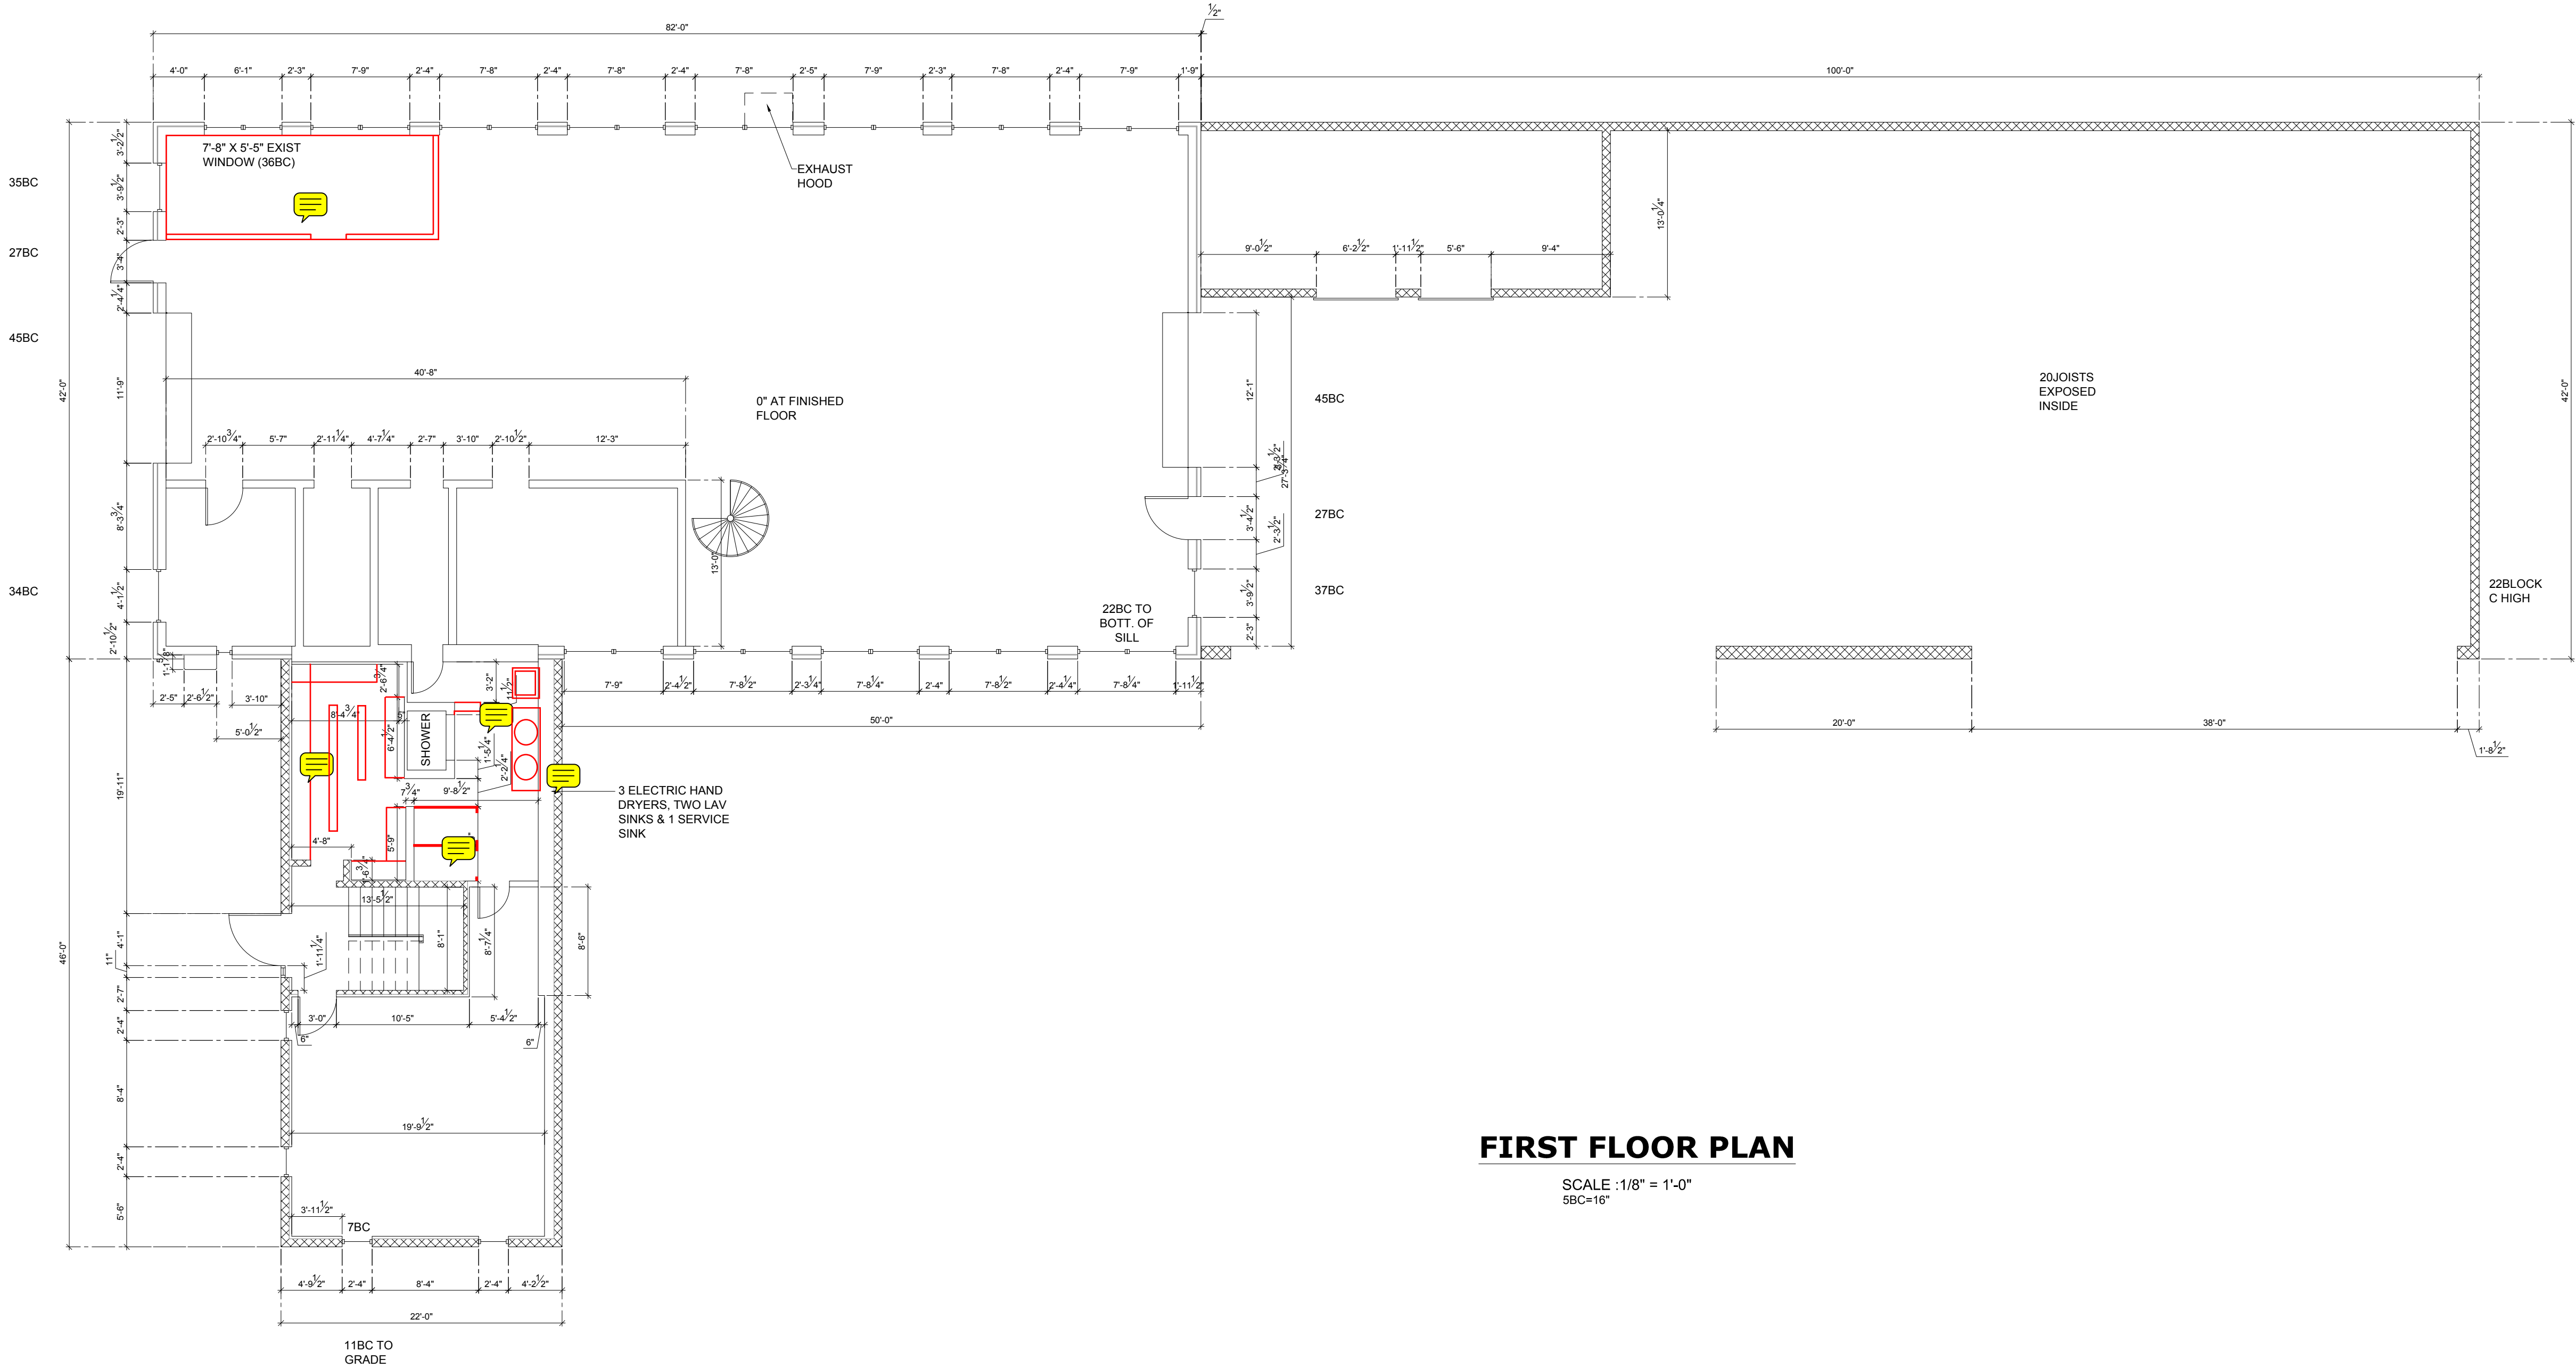

FIRST FLOOR PLAN

SCALE :1/8" = 1'-0"
 5/8"=16"

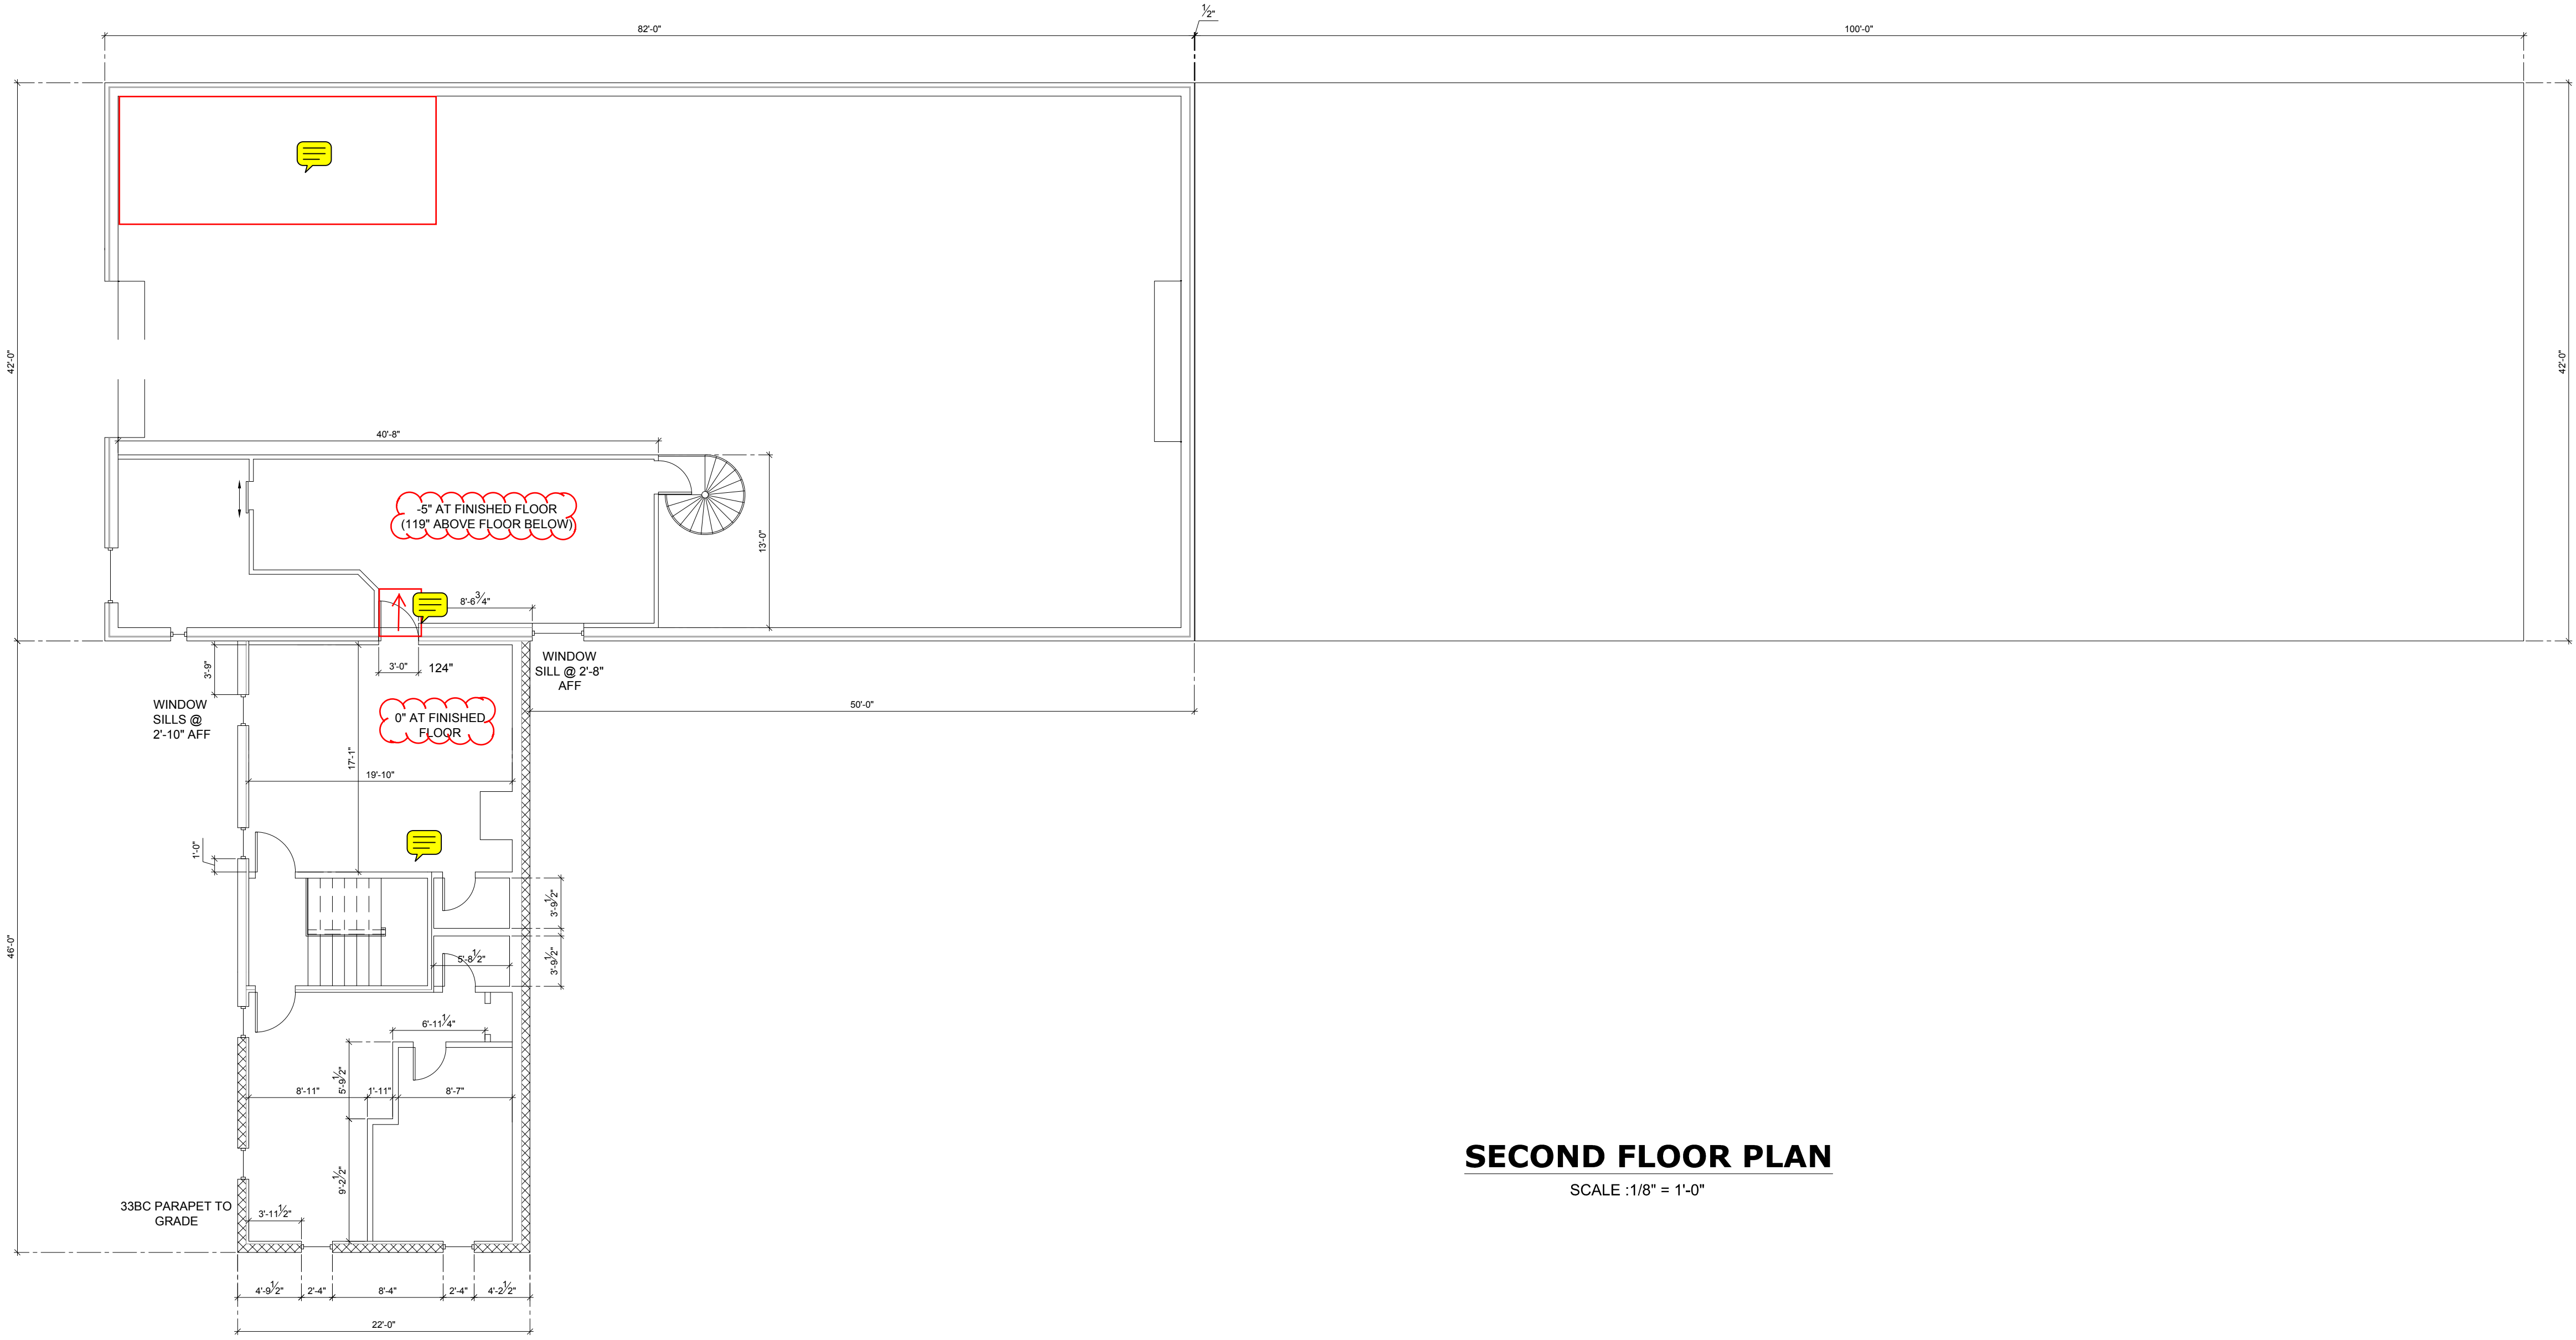

SECOND FLOOR PLAN
 SCALE :1/8" = 1'-0"




CITY OF
 HYATTSVILLE
 DPW BUILDING

SHEET TITLE:
SECOND FLOOR PLAN
 SCALE: 1/8" = 1'-0"


SHEET:
A
2.2

CITY OF
HYATTSVILLE
MARYLAND

- LEGENDS:
- 2'X4' TUBE FLUORESCENT FIXTURE
 - 1'X4' TUBE FLUORESCENT FIXTURE
 - 1'X4' TUBE RECESSED FLUORESCENT FIXTURE
 - 2'X2' TUBE FLUORESCENT FIXTURE
 - SUPPLY AIR GRILLE
 - RETURN AIR GRILLE
 - RESESSED DOWN LIGHT
 - SPRINKLER
 - SMOKE DETECTOR
 - 14"Ø INCANDESCENT DOME FIXTURE SURFACE -MOUNT
 - EMERGENCY LIGHTING
 - EXH.FAN-10" Ø
 - EXH.FAN-6" Ø

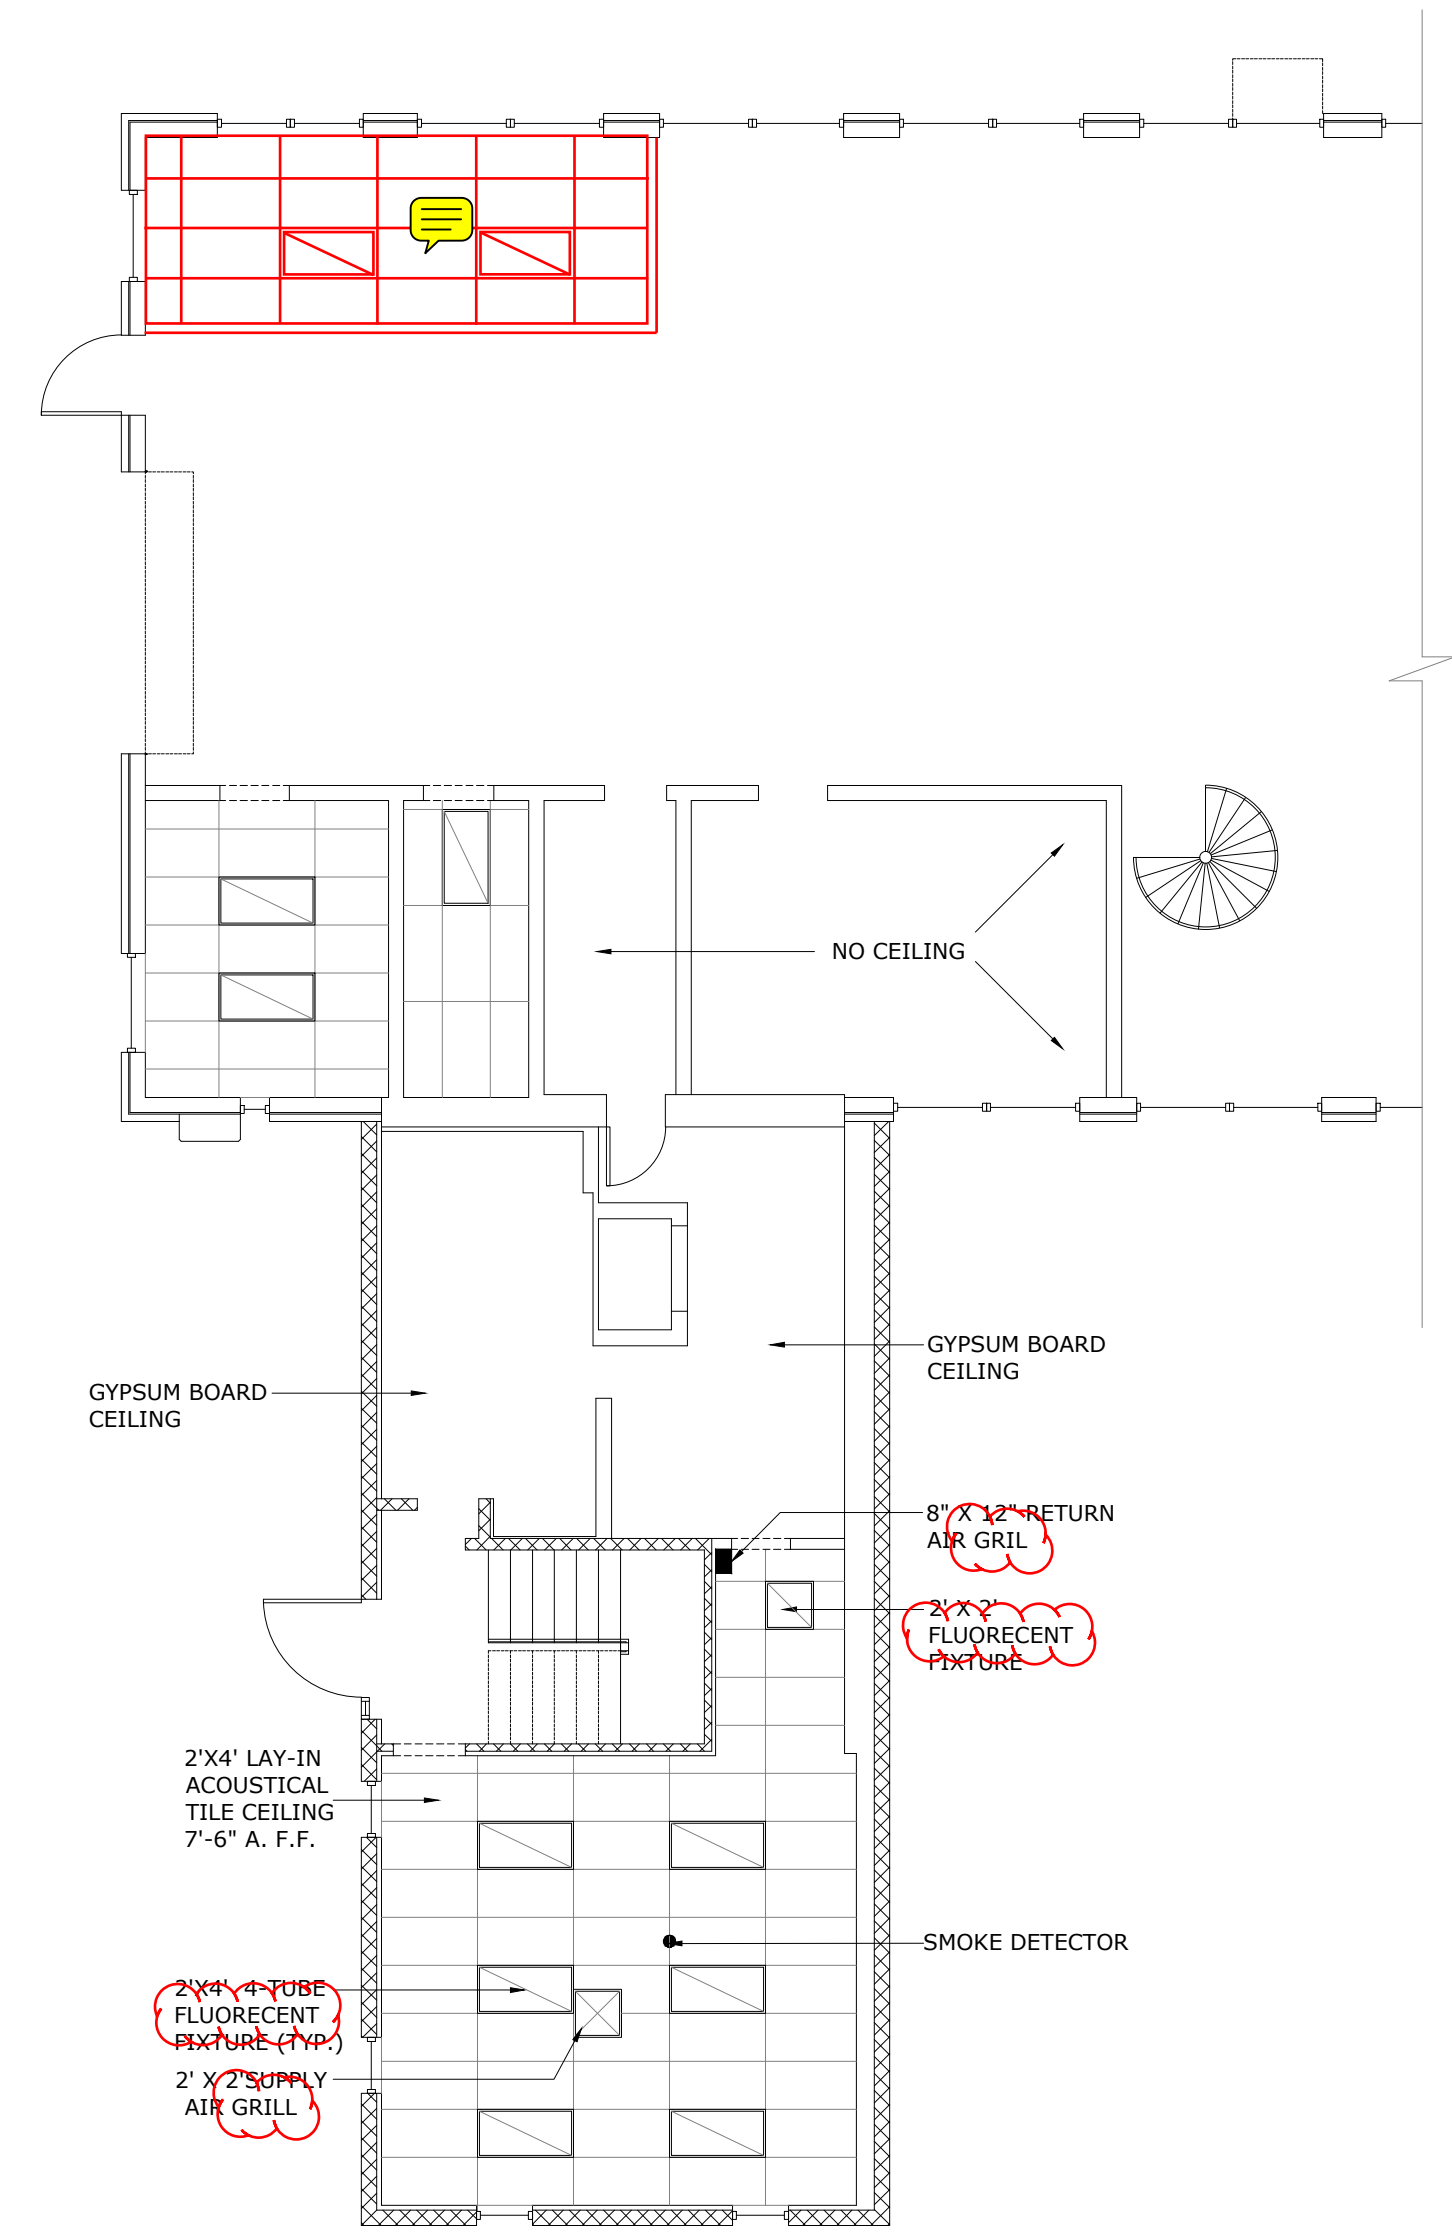

**FIRST FLOOR
REFLECTED CEILING PLAN**
SCALE :1/8" = 1'-0"

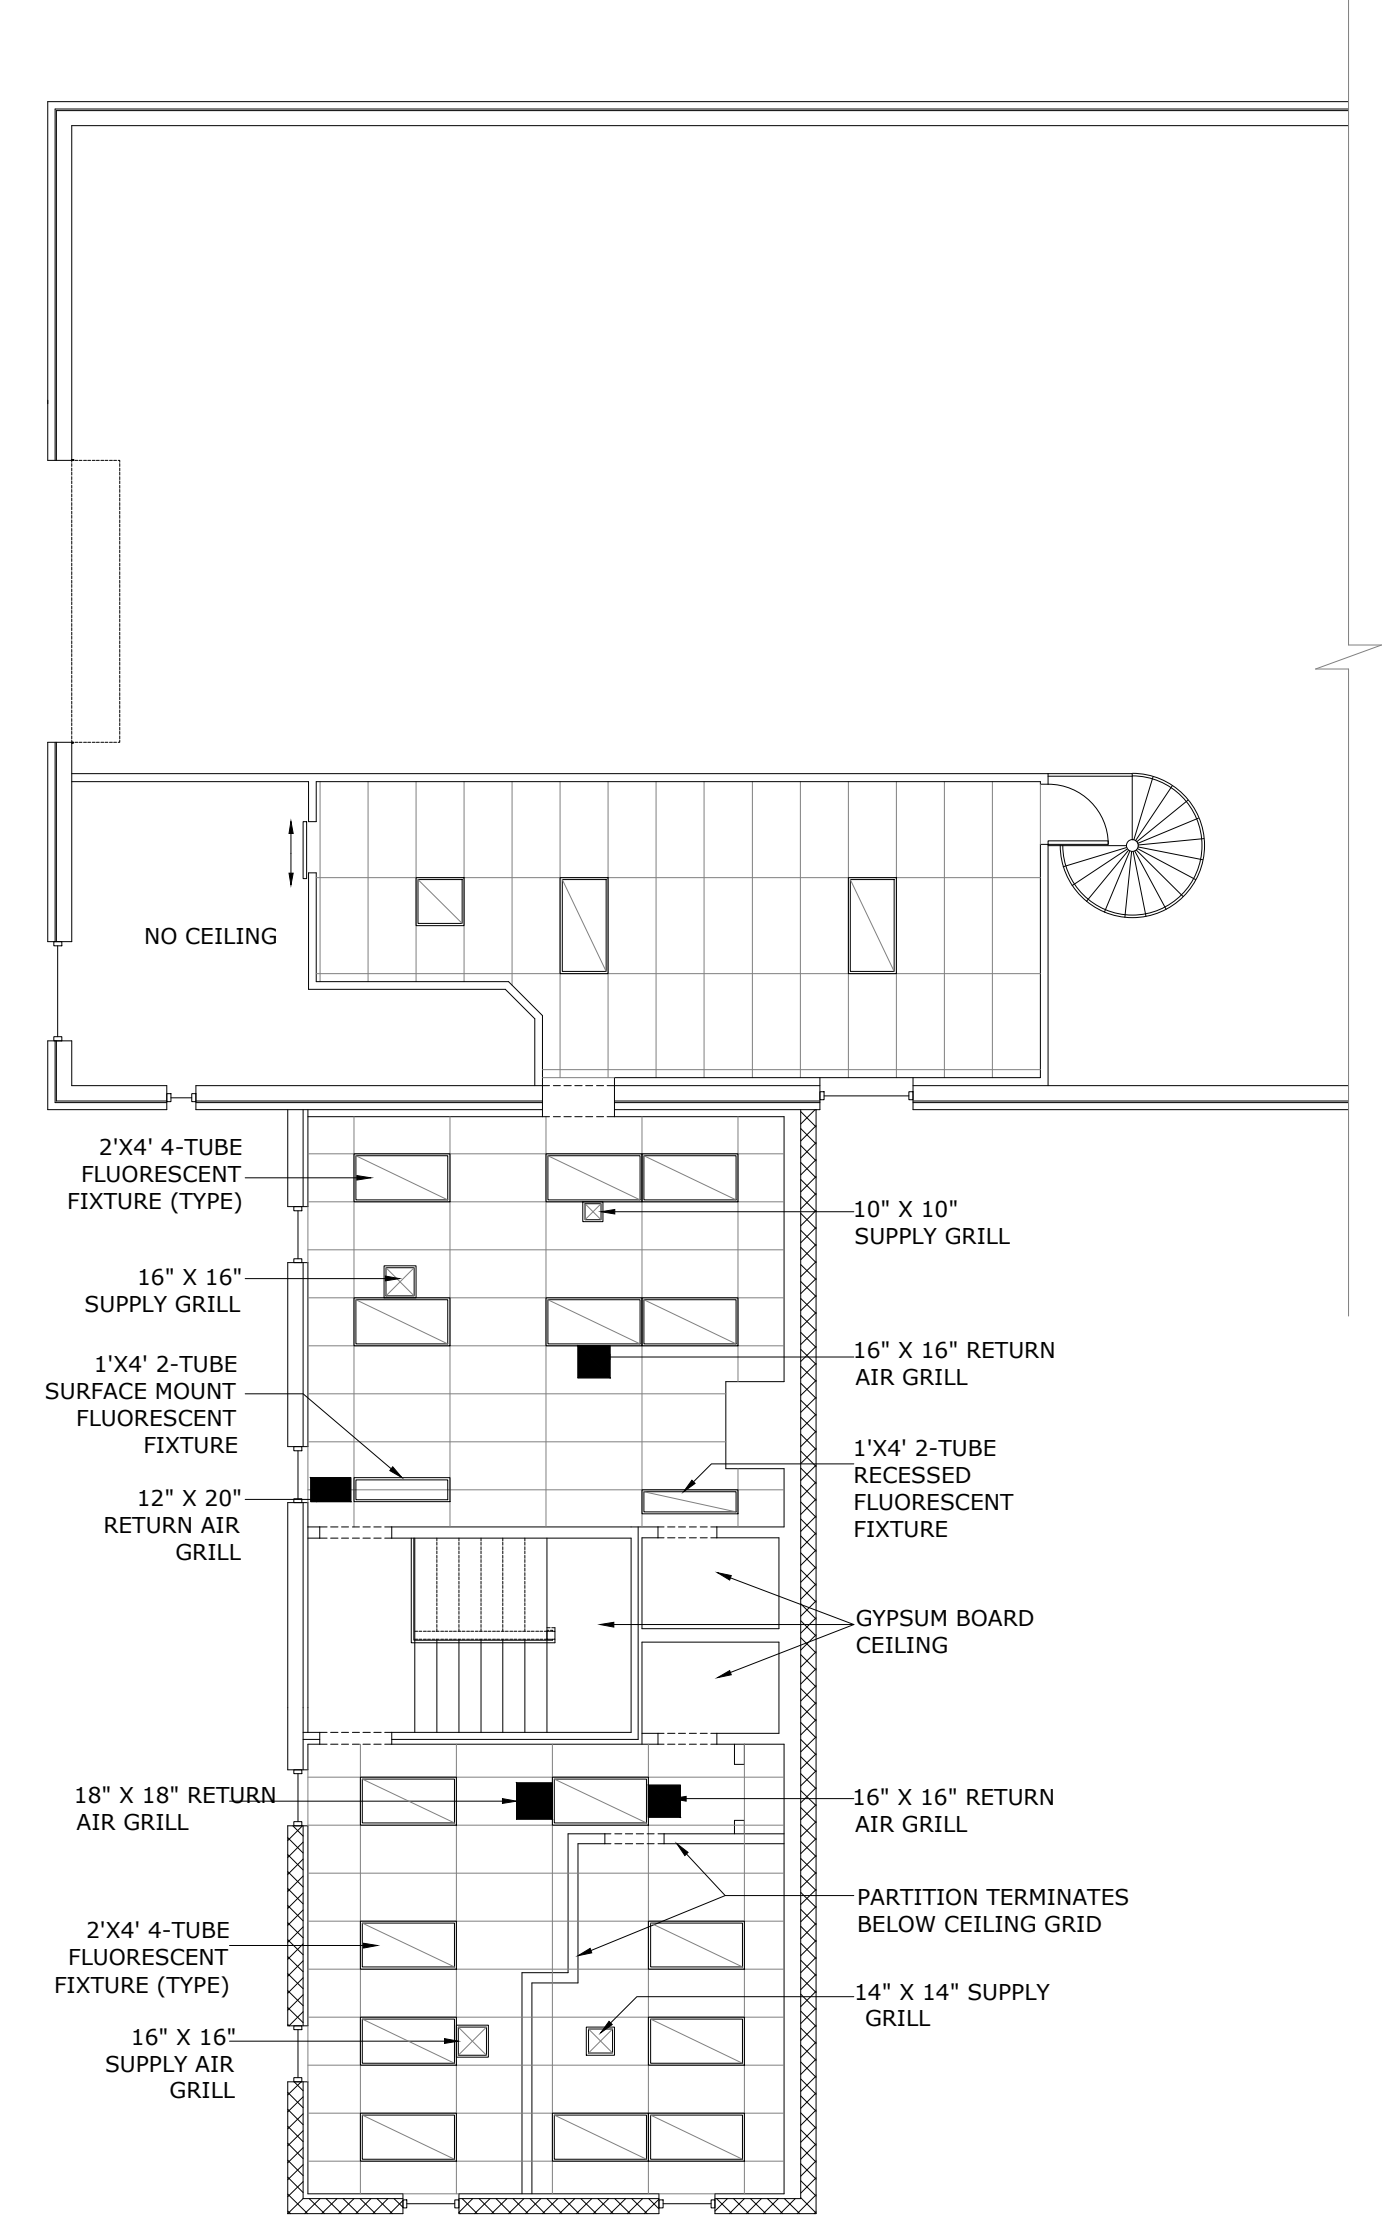

**SECOND FLOOR
REFLECTED CEILING PLAN**
SCALE :1/8" = 1'-0"



CITY OF
HYATTSVILLE
DPW BUILDING

SHEET TITLE:
FIRST & SECOND FLOOR
REFLECTED CEILING PLAN
SCALE: 1/8" = 1'-0"

SHEET:
A
2.3